


Signature \_\_\_\_\_ Date \_\_\_\_\_

CONSTRUCTION OPERATIONS COORDINATION SCHEDULE

LEGEND

GC - GENERAL CONSTRUCTION CONTRACTOR (PROJECT COORDINATOR)  
EC - ELECTRICAL CONTRACTOR  
PM - PROJECT MANAGER (PPA)  
PECO - UTILITY COMPANY  
COMCAST - CABLE COMMUNICATIONS COMPANY

SYSTEM / EQUIPMENT	TASK	COORDINATION					REMARKS	
		GC	EC	PM	PECO	COMCAST		
GENERAL CONSTRUCTION	FOOTINGS AND FOUNDATIONS	●	●	●	●	●		
	INSTALLATION	●	●	●	●	●		
	TRAILER AND STEPS	●	●	●	●	●	PM TO COORDINATE WITH GC FOR DELIVERY AND STORAGE GC TO COORDINATE WITH EC AND PM FOR ELECTRICAL SERVICE AND REVENUE EQUIPMENT.	
	INSTALLATION	●	●	●	●	●		
SITE WORK	FENCES, GATES, BOLLARDS AND EXCAVATION	●	●	●	●	●	GC TO COORDINATE WITH EC AND PM FOR ELECTRICAL CONNECTIONS, COMMUNICATIONS AND REVENUE EQUIPMENT INSTALLATIONS.	
	INSTALLATION	●	●	●	●	●		
	REVENUE EQUIPMENT	●	●	●	●	●	PM TO COORDINATE WITH GC FOR DELIVERY AND STORAGE PM TO COORDINATE WITH EC FOR POWER AND CONTROL WIRING AND WITH GC FOR EQUIPMENT LOCATIONS.	
	INSTALLATION	●	●	●	●	●		
ELECTRICAL	SITE EXCAVATION, TRENCHING AND BACKFILLING	●	●	●	●	●	EC TO COORDINATE WITH GC FOR TRENCH LOCATIONS AND RE-PAVING.	
	INSTALLATION	●	●	●	●	●		
	GRADING	●	●	●	●	●	GC TO COORDINATE WITH EC.	
	CURBWORK AND PAVING	●	●	●	●	●	GC TO COORDINATE WITH EC FOR TRENCHES, POWER AND CONTROL WIRING AND WITH PM FOR REVENUE EQUIPMENT AND TRAILER LOCATIONS.	
	INSTALLATION	●	●	●	●	●		
	PAVEMENT MARKINGS AND SIGNAGE	●	●	●	●	●		
	INSTALLATION	●	●	●	●	●		
	ELECTRICAL AND COMMUNICATIONS SERVICE	PROVIDE MATERIALS	●	●	●	●	●	EC TO COORDINATE WITH PECO AND COMCAST FOR SERVICE AND METER/EQUIPMENT LOCATIONS
INSTALLATION	●	●	●	●	●	EC TO COORDINATE WITH PECO AND COMCAST FOR CONNECTION TO NEW SERVICES AND GC FOR ELECTRICAL EQUIPMENT PLACEMENT.		
POWER	PROVIDE MATERIALS	●	●	●	●	●		
	INSTALLATION	●	●	●	●	●	EC TO COORDINATE WITH GC AND PM FOR ELECTRICAL CONNECTIONS AND REVENUE EQUIPMENT AND TRAILER LOCATIONS.	
	COMMUNICATIONS AND CONTROL WIRING	PROVIDE MATERIALS	●	●	●	●	●	EC TO COORDINATE WITH GC AND PM FOR ELECTRICAL AND COMMUNICATIONS CONNECTIONS AND REVENUE EQUIPMENT LOCATIONS.
	INSTALLATION	●	●	●	●	●		
SURVEILLANCE SYSTEM	PROVIDE MATERIALS	●	●	●	●	●	EC TO COORDINATE WITH GC AND PM FOR ELECTRICAL CONNECTIONS, REVENUE EQUIPMENT LOCATIONS AND SURVEILLANCE SYSTEM INTEGRATION.	
INSTALLATION	●	●	●	●	●			

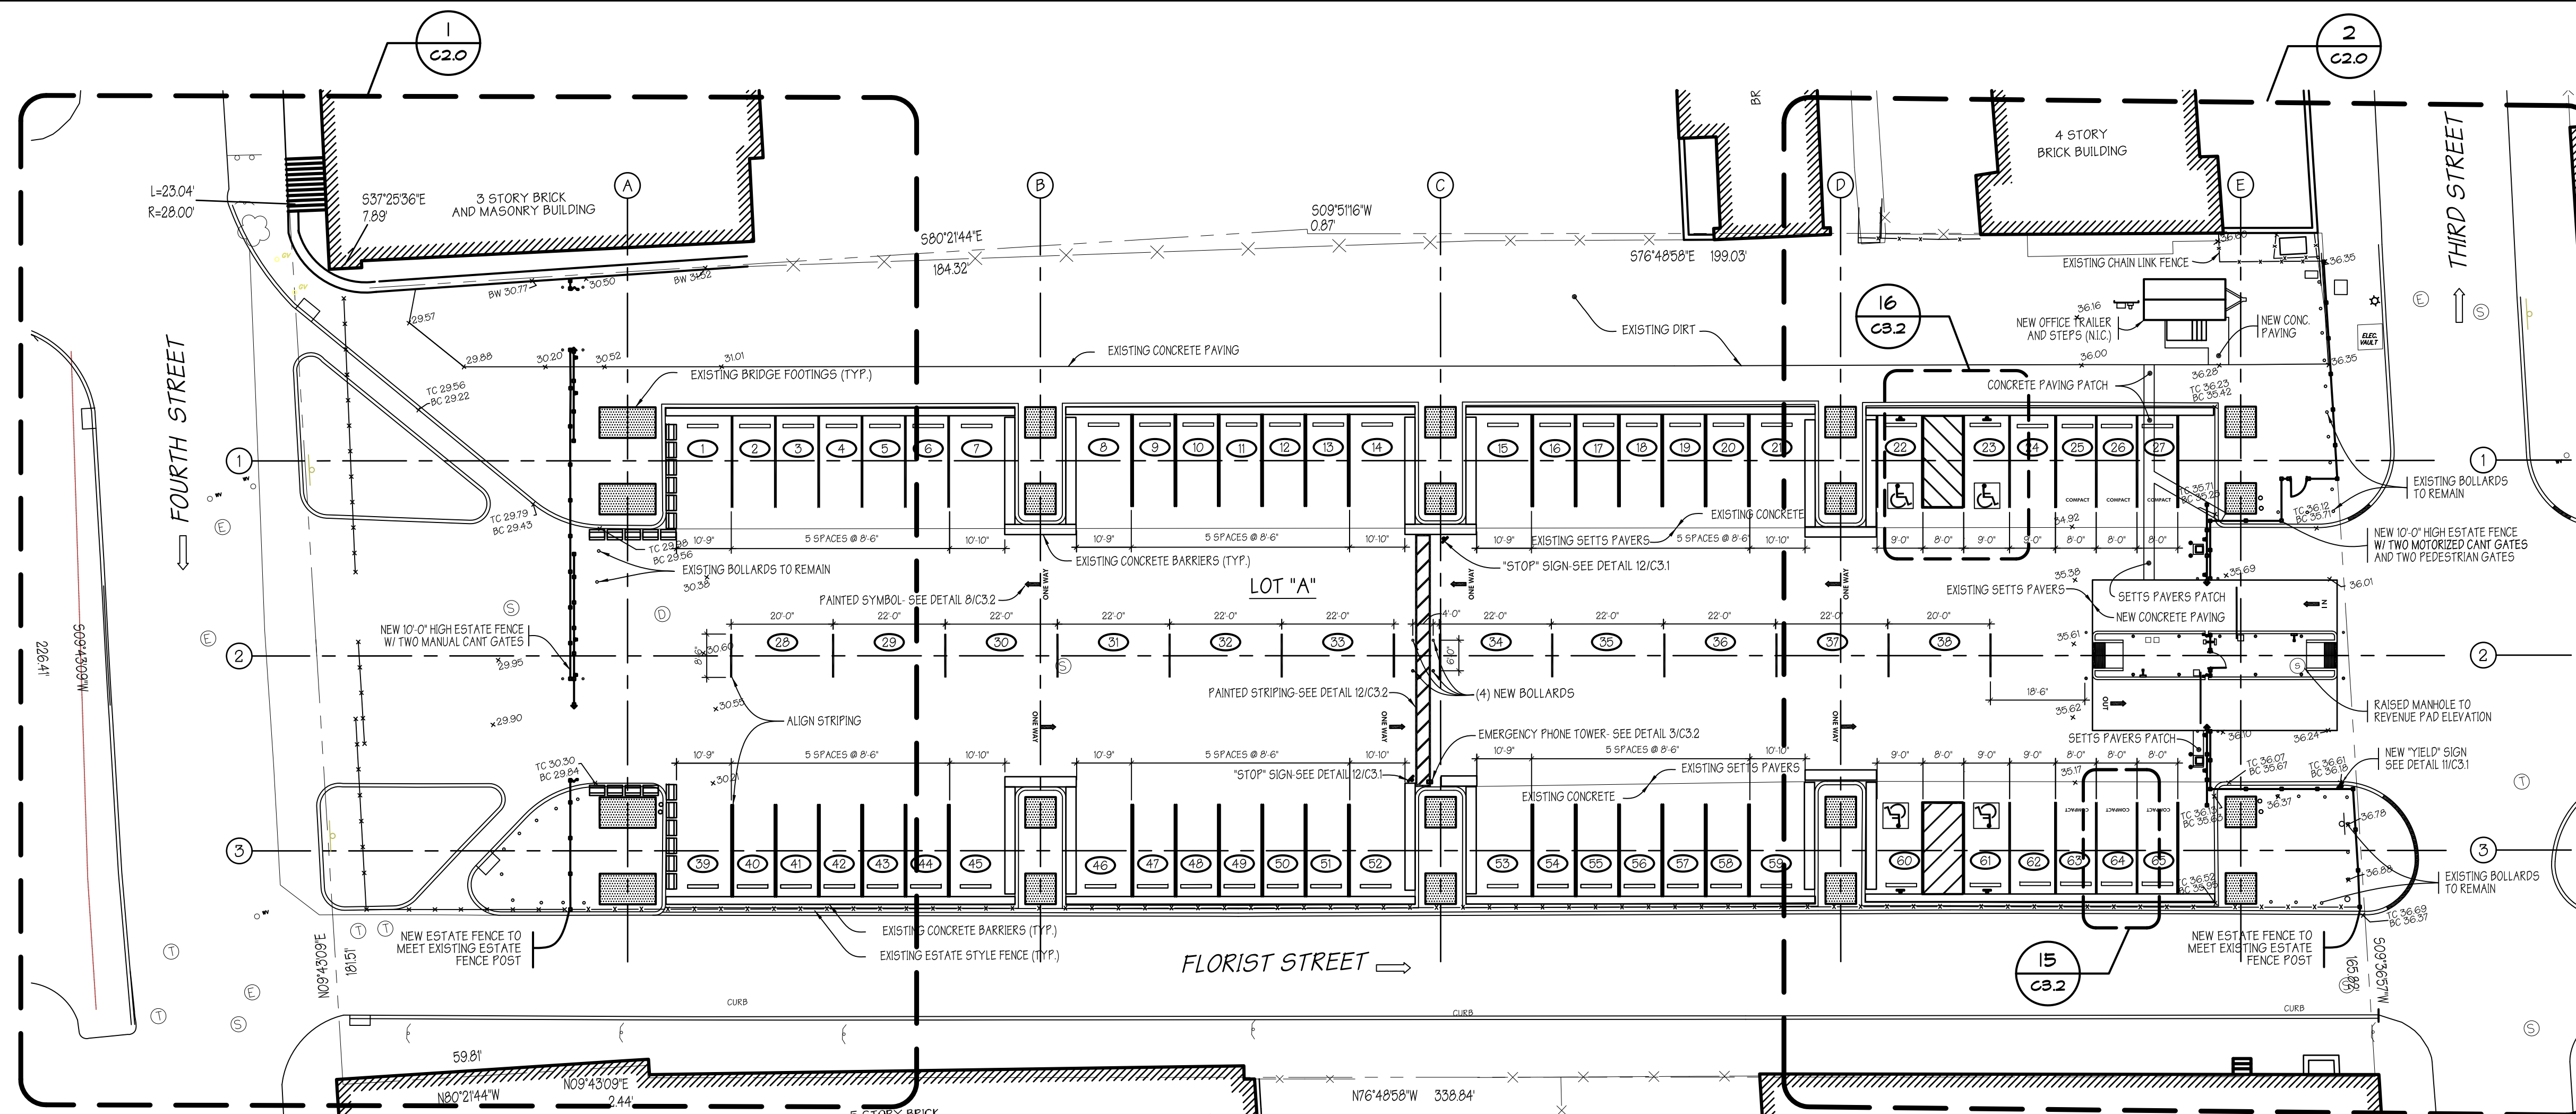

1 SITE PLAN - LOT "A"  
C1.0 SCALE: 1"=20'-0"

ALL INFORMATION PROVIDED ON THIS DOCUMENT IS THE PROPERTY OF THE FIRM OF CARLOS RAUL RODRIGUEZ ARCHITECT AND IS NOT TO BE COPIED, REPRODUCED OR OTHERWISE DISTRIBUTED AND UTILIZED WITHOUT WRITTEN PERMISSION. ONLY DOCUMENTS THAT ARE SIGNED AND SEALED BY CARLOS RAUL RODRIGUEZ ARCHITECT MAY BE RELIED UPON AS BEING AN AUTHENTIC, AUTHORIZED DOCUMENT ISSUED BY CARLOS RAUL RODRIGUEZ ARCHITECT. CARLOS RAUL RODRIGUEZ ARCHITECT SHALL NOT BE HELD RESPONSIBLE FOR ANY ALTERATIONS AND/OR MODIFICATIONS MADE BY OTHERS TO THESE DOCUMENTS.

© Copyright 2016 Carlos Raul Rodriguez Architect

REVISIONS

NO.	DATE	DESCRIPTION
C	RRR 18JAN17	REVISIONS PER ADDENDUM #1
B	RRR 6JAN17	ISSUED FOR PUBLIC BID
A	RRR 15DEC16	ISSUED FOR REVIEW NOT FOR CONSTRUCTION



PROJECT NORTH

**BID NO. 16-32**  
PROPOSED PARKING LOTS AT  
THE BENJAMIN FRANKLIN BRIDGE  
AND THIRD STREET  
PHILADELPHIA, PA

SITE PLAN  
CONSTRUCTION OPERATIONS  
COORDINATION SCHEDULE

DATE: 15 DEC 2016 DRAWN BY:  
PROJECT NO.: 1601-10 SHEET 5 OF 21

**C1.0**