



O'DONNELL & NACCARATO, INC.
PROJECT MANAGERS
111 SOUTH INDEPENDENCE MALL EAST
SUITE 950
PHILADELPHIA, PENNSYLVANIA 19106-2524
TELEPHONE: (215) 925-3798
FAX: (215) 627-1051





WALKER
PARKING CONSULTANTS

100 Four Falls Corporate Ctr.
Suite 310
W. Conshohocken, PA
610.940.5800 Ph.
610.940.5808 Fax



SPECTRA
Engineering, Inc.
SIXTH FLOOR
511 NORTH BROAD STREET
PHILADELPHIA, PA 19123
TEL: (215) 829-9690 FAX: (215) 829-9666
E-MAIL: SPECTRAE@IX.NETCOM.COM

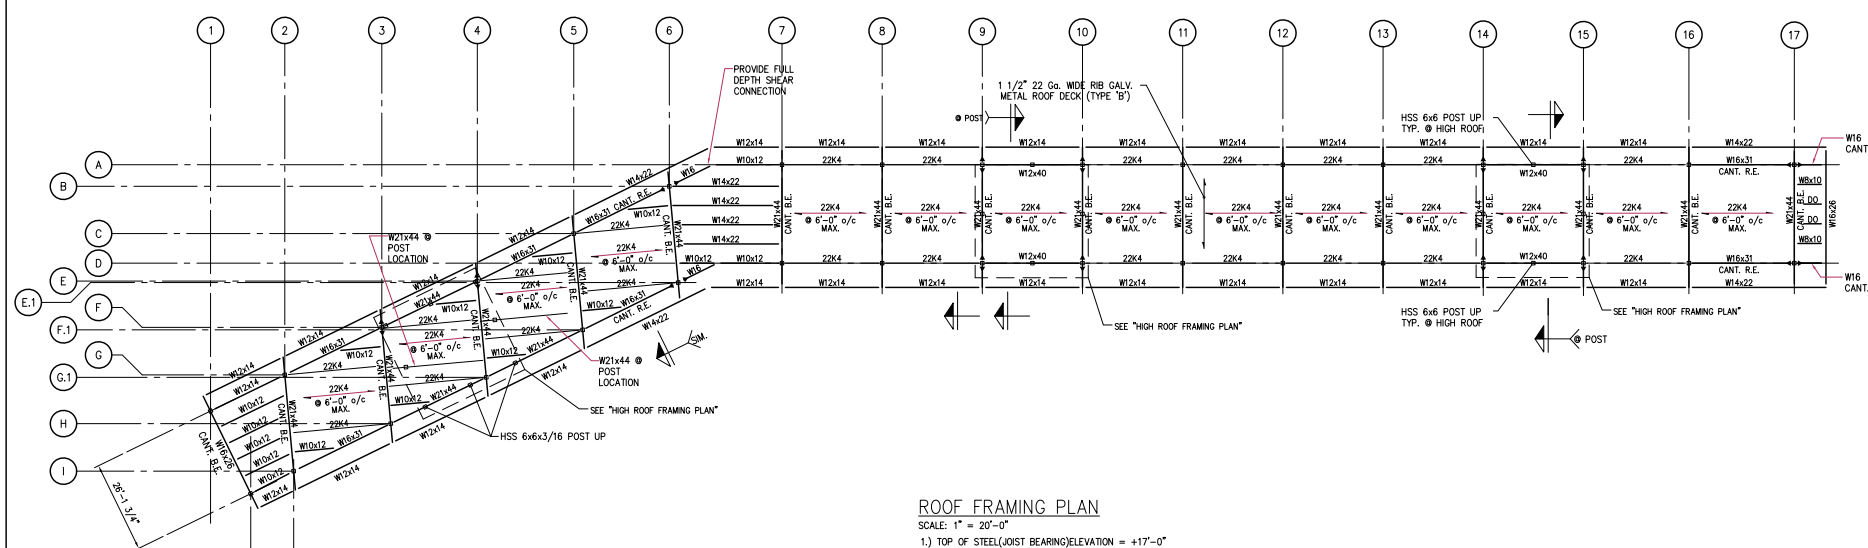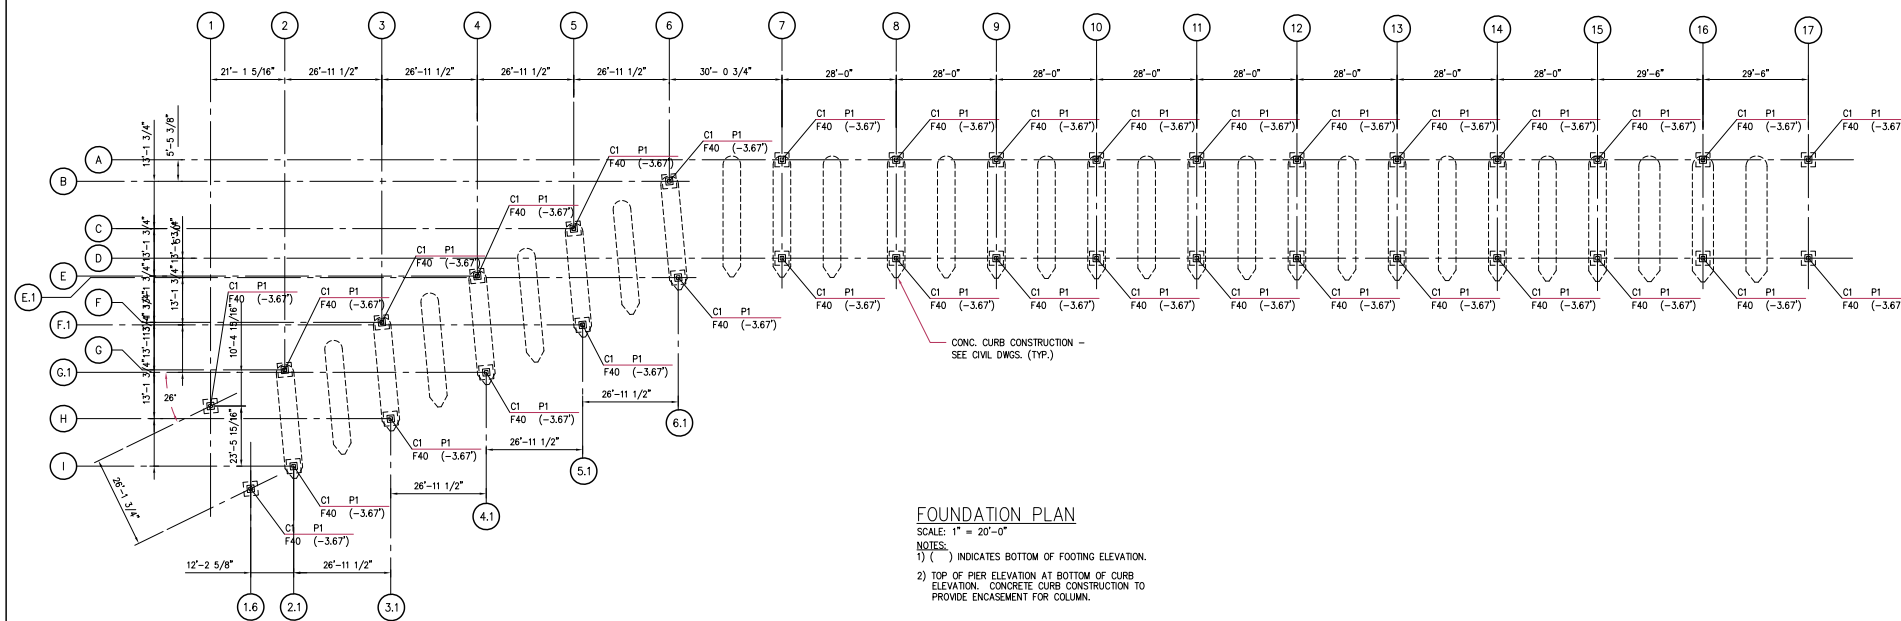

COLUMN SCHEDULE			
MARK	SIZE (V50)	BASE PLATE (A36)	A.B. (A36)
C1	HSS 6x6x3/16	3/4 x 12 x 1'-0"	(4) 3/4" φ

PIER SCHEDULE		
MARK	SIZE	REINFORCING
P1	16" x 16" CONC.	(4) #7 VERT. w/#3 TIES @ 12"

FOOTING SCHEDULE		
MARK	SIZE	REINFORCING
F40	4'-0" x 4'-0" x 12"	(5) #4 EWB

PPA
Philadelphia Parking Authority

3101 MARKET STREET
2ND FLOOR
PHILADELPHIA, PA 19104

Revisions		
No.	Date	Description
1	00	DOA SUBMISSION
2	7/10/00	ISSUED FOR BIDDING
3	01/09/01	CONSOLIDATED DRAWING SET

Project
PHILADELPHIA INTERNATIONAL
AIRPORT
ADMINISTRATION
FACILITIES
BID # 9906.PHL

Drawing
FOUNDATION &
FRAMING PLAN

Scale AS NOTED
Job MSA
Drawn J.J.B.
Date 9/7/99
Sheet T-S1